


VARIOUS HOUSING - ALM STREET



SHEET NUMBER	SHEET NAME
AD00.00	COVER SHEET - ALM STREET
AD01.00	DEMOLITION PLAN - ALM STREET
AD01.01	OVERALL SIT PLAN - ALM STREET
AD02.01	FLOOR PLAN - ALM STREET
AD02.02	ROOF PLAN - ALM STREET
AD03.01	PLUMBING PLAN - ALM STREET
AD03.02	ELECTRICAL PLAN - ALM STREET
AD04.01	ELEVATION SHEET - ALM STREET
AD04.02	SECTION SHEET - ALM STREET

 db ARCH	dbARCH planning architecture interior design project management 1-3 Clacherty Street PO Box 191 Stratford QLD 4870 Australia +61 7 4058 0290 www.dbarch.com.au	North 	Drawing Status PRELIMINARY ISSUE Scale 0m0m0m0m0m0m SCALE 1:0	Revision Schedule <table><tr><td>P4 PRELIMINARY ISSUE</td><td>08.11.17</td></tr><tr><td>P3 PRELIMINARY ISSUE</td><td>06.07.17</td></tr><tr><td>P2 PRELIMINARY ISSUE</td><td>21.06.17</td></tr><tr><td>P1 PRELIMINARY ISSUE</td><td>20.06.17</td></tr></table> Rev Description Date	P4 PRELIMINARY ISSUE	08.11.17	P3 PRELIMINARY ISSUE	06.07.17	P2 PRELIMINARY ISSUE	21.06.17	P1 PRELIMINARY ISSUE	20.06.17	Client 	Project Manager / Structural Engineer: 	Drawn Author Date 08.11.17 Verification Checker Partner Designer	Site information:	Project Description VARIOUS HOUSING Drawing Title COVER SHEET - ALM STREET Master Site Number 17HAI01 Drawing Number AD00.00 Revision P 4	Scale: @ A3
	P4 PRELIMINARY ISSUE	08.11.17																
	P3 PRELIMINARY ISSUE	06.07.17																
	P2 PRELIMINARY ISSUE	21.06.17																
P1 PRELIMINARY ISSUE	20.06.17																	


NOTE: This drawing is copyright and the property of dbARCH and must not be used without written authorisation. **DO NOT SCALE THIS DRAWING.** All dimensions are to be verified onsite and any discrepancies reported before commencement of any work or shop drawings.

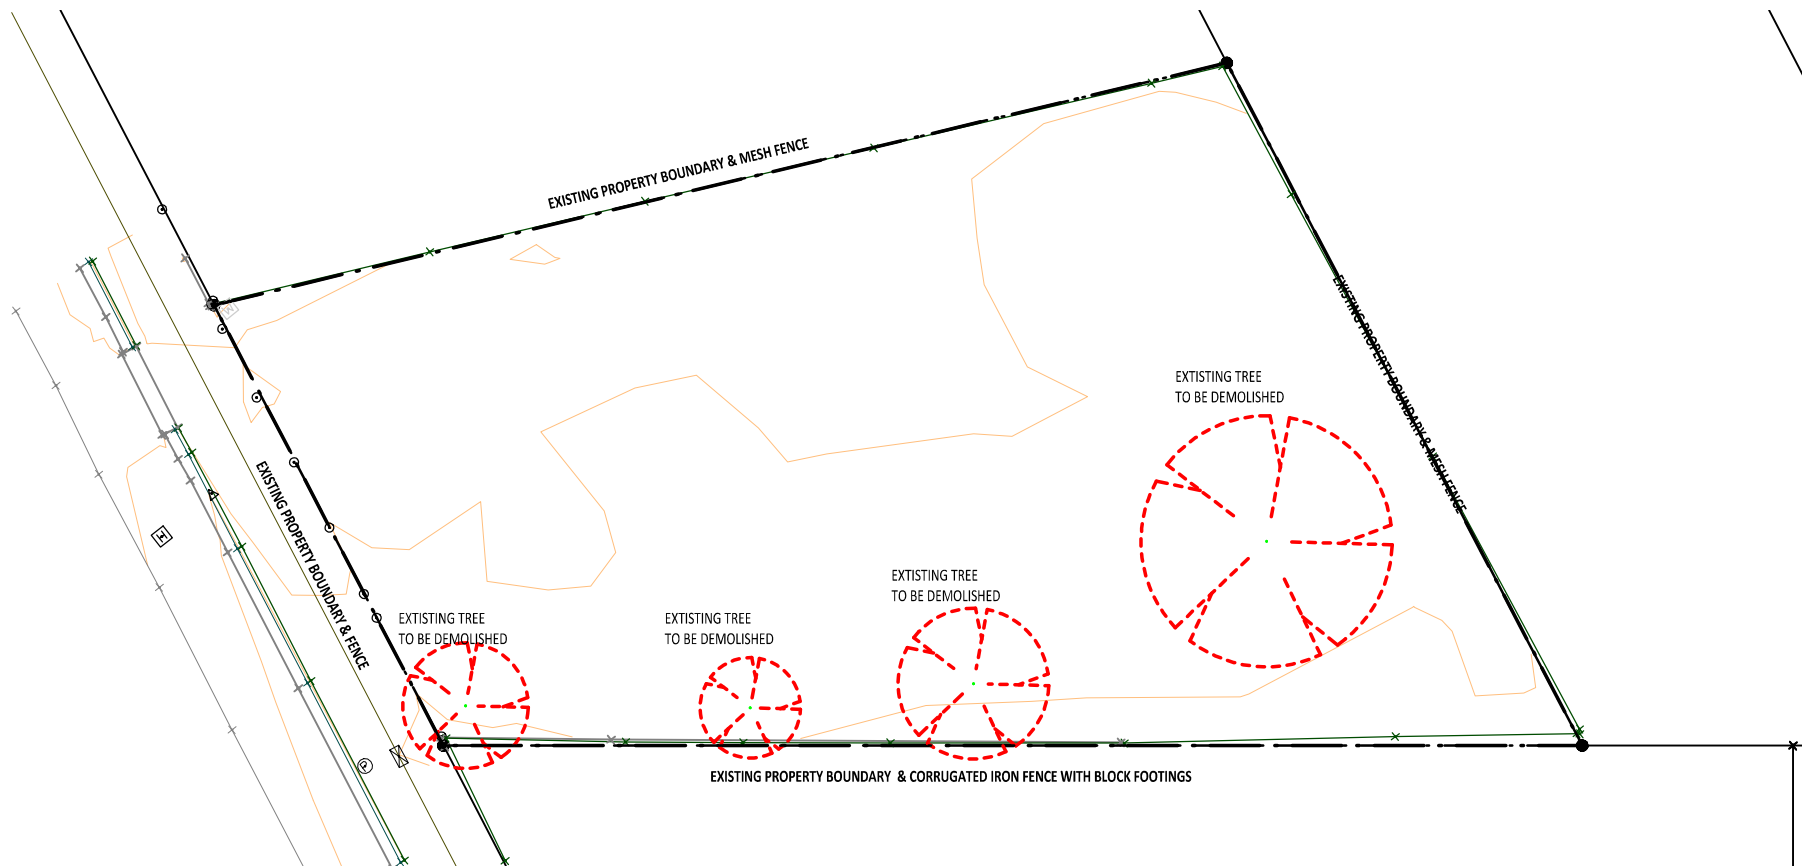

1 SITE PLAN - DEMLOITION ALM STREET
AA04.01 1 : 200



dbARCH
planning
architecture
interior design
project management
1-3 Clacherty Street | PO Box 191
Stratford QLD 4870 Australia
+61 7 4058 0290 | www.dbarch.com.au

 

Drawing Status
PRELIMINARY ISSUE
Scale
0m 2m 4m 6m 8m 10m
SCALE 1:200

Revision Schedule	
P4 PRELIMINARY ISSUE	08.11.17
P3 PRELIMINARY ISSUE	06.07.17
P2 PRELIMINARY ISSUE	21.06.17
P1 PRELIMINARY ISSUE	20.06.17
Rev	Description
	Date



Project Manager /
Structural Engineer:
LANDSCAPE & DESIGN
LANDSCAPE & DESIGN

Drawn
Author
Date
08.11.17
Verification
Checker
Partner
Designer

Site information:


Project Description VARIOUS HOUSING	
Drawing Title DEMOLITION PLAN - ALM STREET	Scale 1 : 200 @
Master Site Number 17HAI01	Drawing Number AD01.00
	Revision P 4

NOTE: This drawing is copyright and the property of dbARCH and must not be used without written authorisation. **DO NOT SCALE THIS DRAWING.** All dimensions are to be verified onsite and any discrepancies reported before commencement of any work or shop drawings.

REAL PROPERTY DESCRIPTION

Lot 11 on RP717839
8 Alm Street
INGHAM
Local Govt: Hinchinbrook Shire

100 YEAR FLOOR ARI : 13.2m
FREE BOARD : 0.3m
MINIMUM FFL : 13.5m AHD

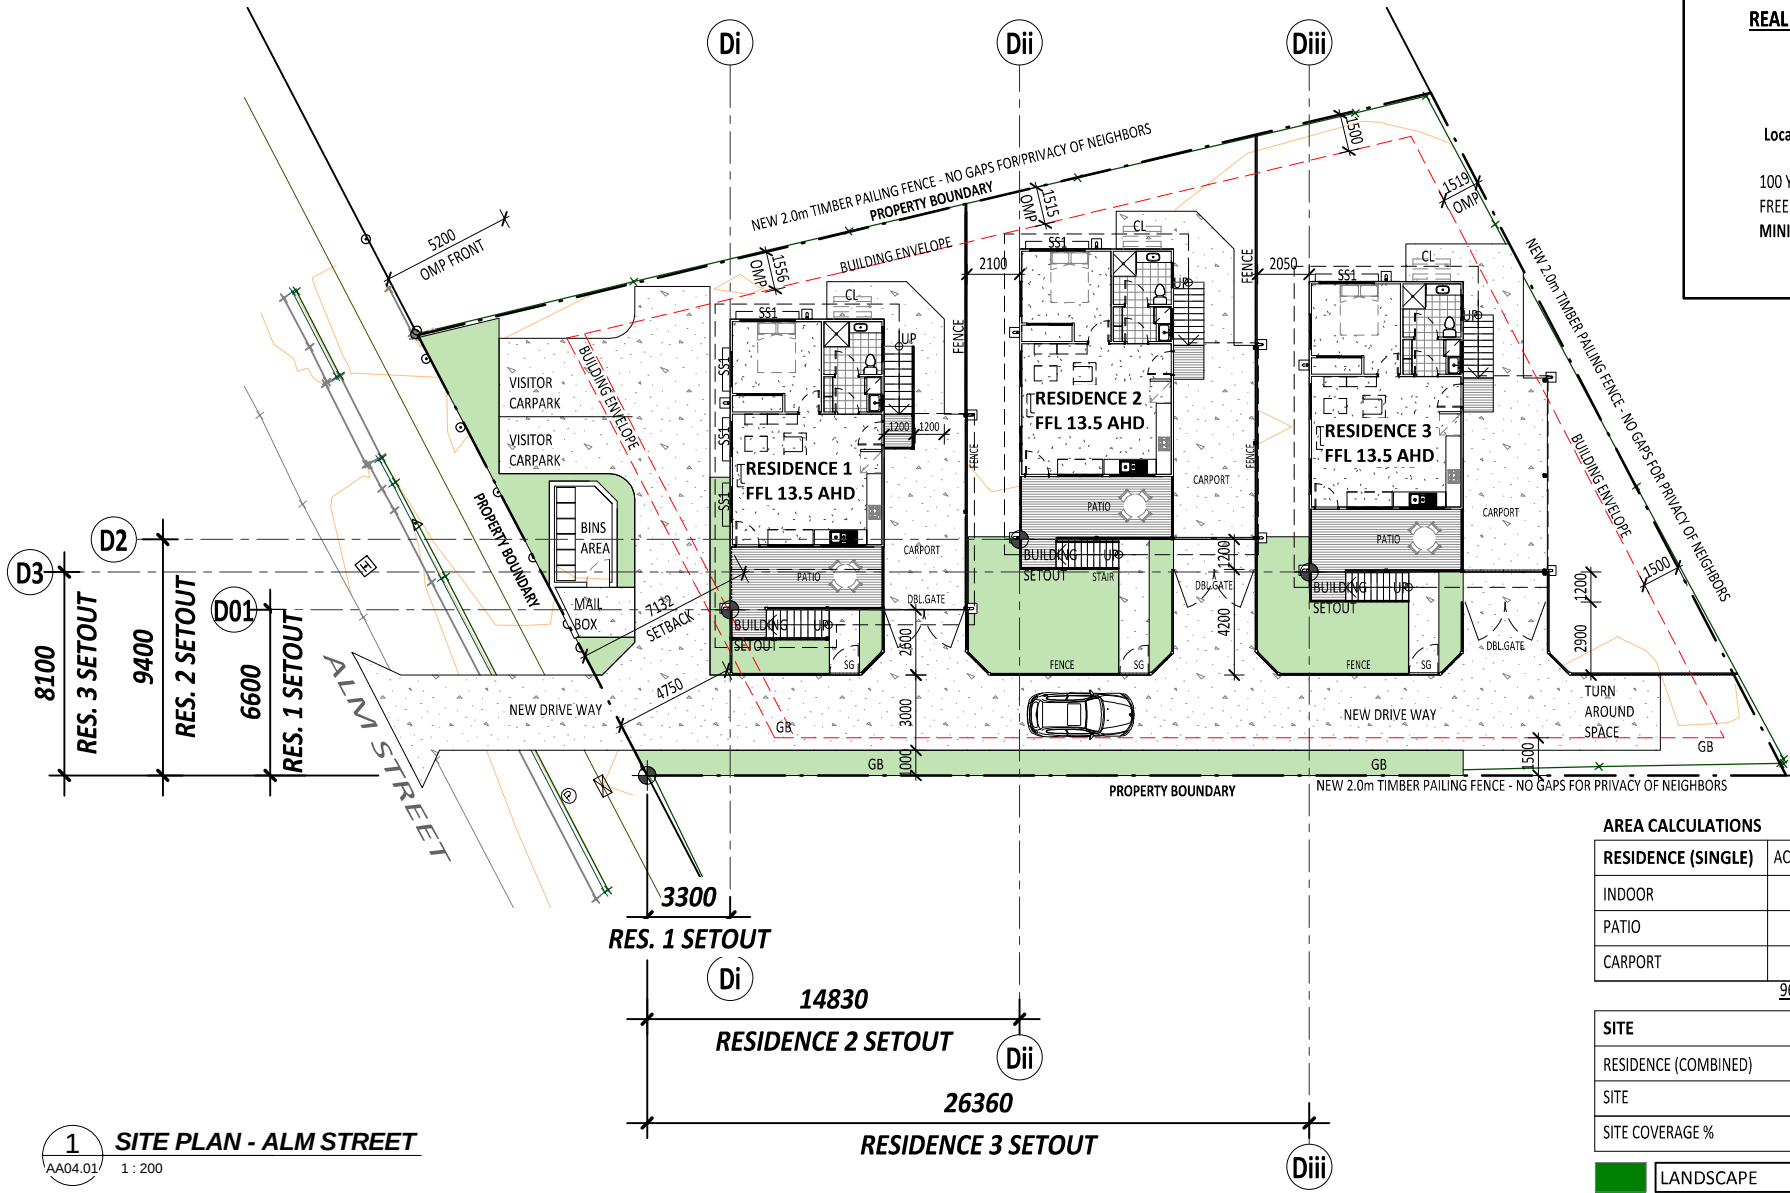

AREA CALCULATIONS

RESIDENCE (SINGLE)	ACHIEVED sqm	REQUIRED
INDOOR	55	55
PATIO	15	15
CARPORT	26	

96sqm GROSS BUILDING AREA


SITE	REQUIRED
RESIDENCE (COMBINED)	288
SITE	1014
SITE COVERAGE %	28.4 %

LANDSCAPE	134 m ²
-----------	--------------------

1 SITE PLAN - ALM STREET
AA04.01 1 : 200



dbARCH
planning
architecture
interior design
project management
1-3 Clacherty Street | PO Box 191
Stratford QLD 4870 Australia
+61 7 4058 0290 | www.dbarch.com.au

 

Drawing Status
PRELIMINARY ISSUE
Scale
0m 2m 4m 6m 8m 10m
SCALE 1:200

Revision Schedule	
P5 AREA CALCULATIONS	04.11.17
P4 PRELIMINARY ISSUE	08.11.17
P3 PRELIMINARY ISSUE	06.07.17
P2 PRELIMINARY ISSUE	21.06.17
Rev Description	Date



Project Manager /
Structural Engineer:
LANDSCAPE & DESIGN
LANDSCAPE & DESIGN
LANDSCAPE & DESIGN

Drawn
Author
Date
04.11.17
Verification
Checker
Partner
Designer

Site information:

Project Description
VARIOUS HOUSING


Drawing Title
OVERALL SIT PLAN - ALM STREET

Master Site Number
17HAI01

Drawing Number
AD01.01

Scale
1 : 200 @
Revision
A3
Revision
P 5

NOTE: This drawing is copyright and the property of dbARCH and must not be used without written authorisation. DO NOT SCALE THIS DRAWING. All dimensions are to be verified onsite and any discrepancies reported before commencement of any work or shop drawings.

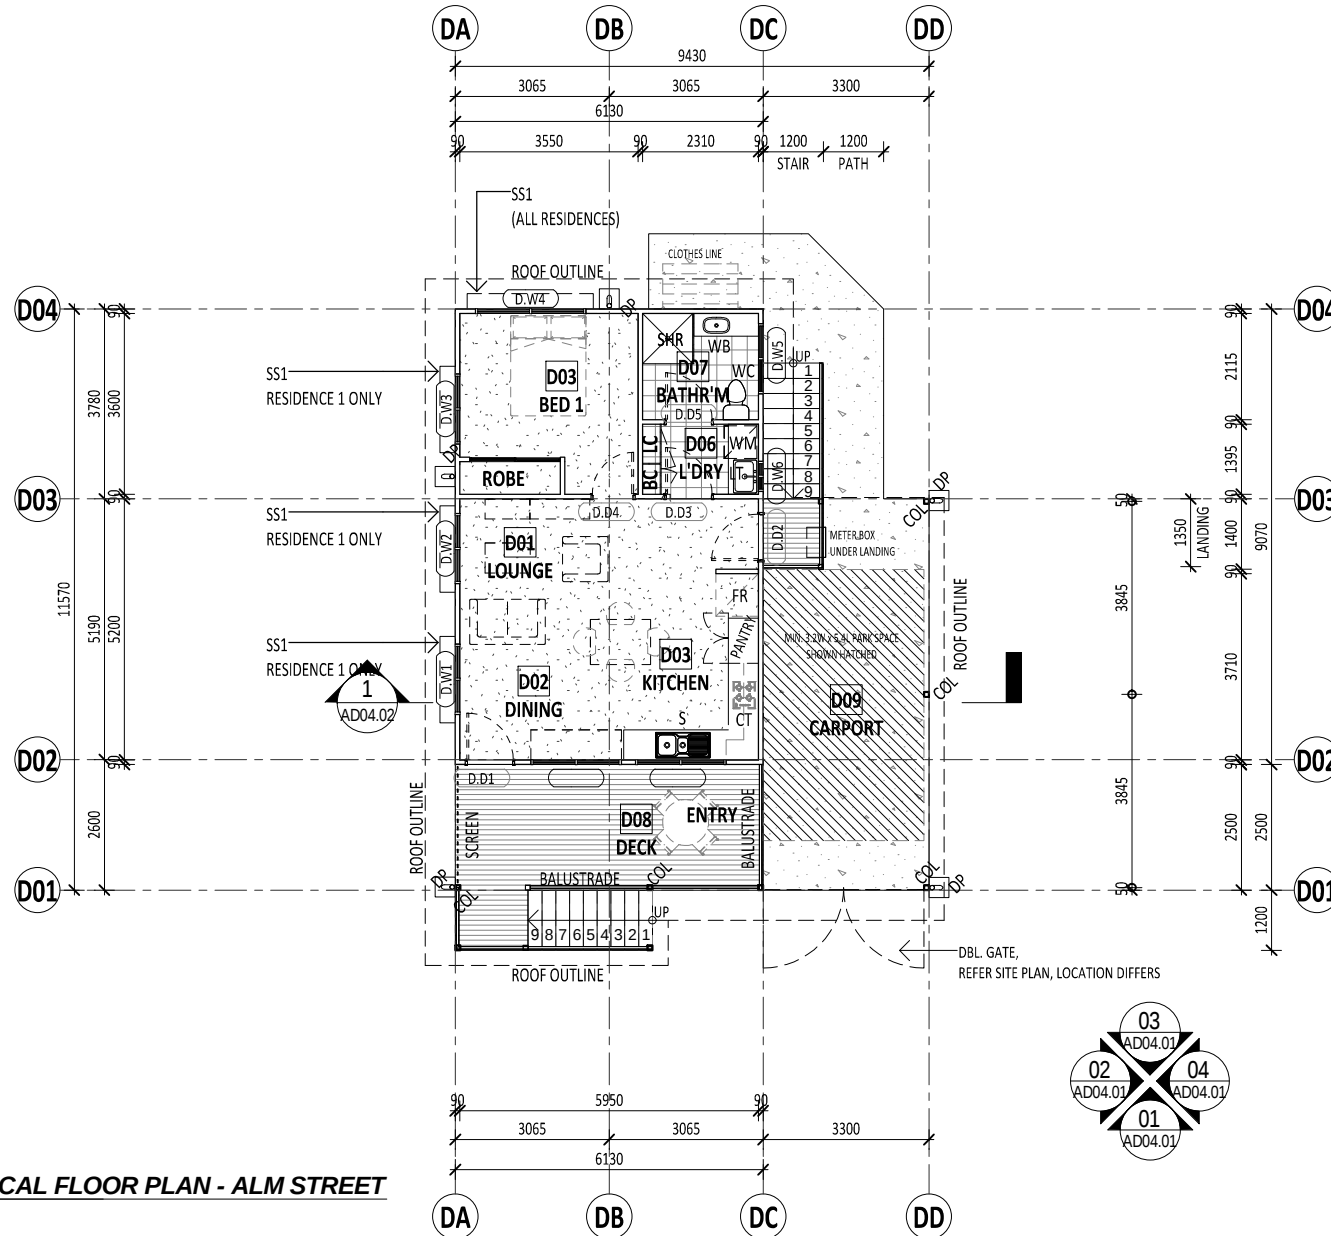

LEGEND

COL	COLUMN
CT	COOKTOP
DP	DOWNPIPE
FR	
LT	
S	SINK
SHR	SHOWER
WB	WASH BASIN
WC	WATER CLOSET
WM	WASHING MACHINE


ROOM SCHEDULE D

Number	Name	Area	REQUIRED AREA*	DIFFERENCE
D01	LOUNGE	14 m ²		
D02	DINING	7 m ²		
D03	BED 1	11 m ²	11 m ²	0 m ²
D04	KITCHEN	8 m ²		
D06	ROBE	1 m ²		
D06	L'DRY	3 m ²		
D07	BATH'R'M	5 m ²		
D08	DECK	15 m ²		
D09	CARPORT	21 m ²		
D12	ROBE	1 m ²		
D14	ROBE	1 m ²		
D15	ROBE	1 m ²		

Grand total: 12

FECA: 55.5 sqm


DECK: 15 sqm

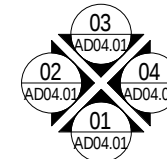

1 TYPICAL FLOOR PLAN - ALM STREET
1 : 100



dbARCH
planning
architecture
interior design
project management
1-3 Clacherty Street | PO Box 191
Stratford QLD 4870 Australia
+61 7 4058 0290 | www.dbarch.com.au

 

Drawing Status

PRELIMINARY ISSUE

Scale

0m 1m 2m 3m 4m 5m

SCALE 1:100

Revision Schedule

P 3 PRELIMINARY ISSUE	08.11.17
P 2 PRELIMINARY ISSUE	21.06.17
P 1 PRELIMINARY ISSUE	20.06.17
Rev Description	Date

Client



Project Manager /
Structural Engineer:

LANDSCAPE & RESIDENTIAL
DESIGN & CONSTRUCTION

Drawn

Author

Date

08.11.17

Verification

Checker

Partner

Designer

Site information:

Project Description

VARIOUS HOUSING

Drawing Title
FLOOR PLAN - ALM STREET

Master Site Number

17HAI01

Drawing Number

AD02.01


Scale
1 : 100 @

A3

Revision

P 3


NOTE: This drawing is copyright and the property of dbARCH and must not be used without written authorisation. **DO NOT SCALE THIS DRAWING.** All dimensions are to be verified onsite and any discrepancies reported before commencement of any work or shop drawings.

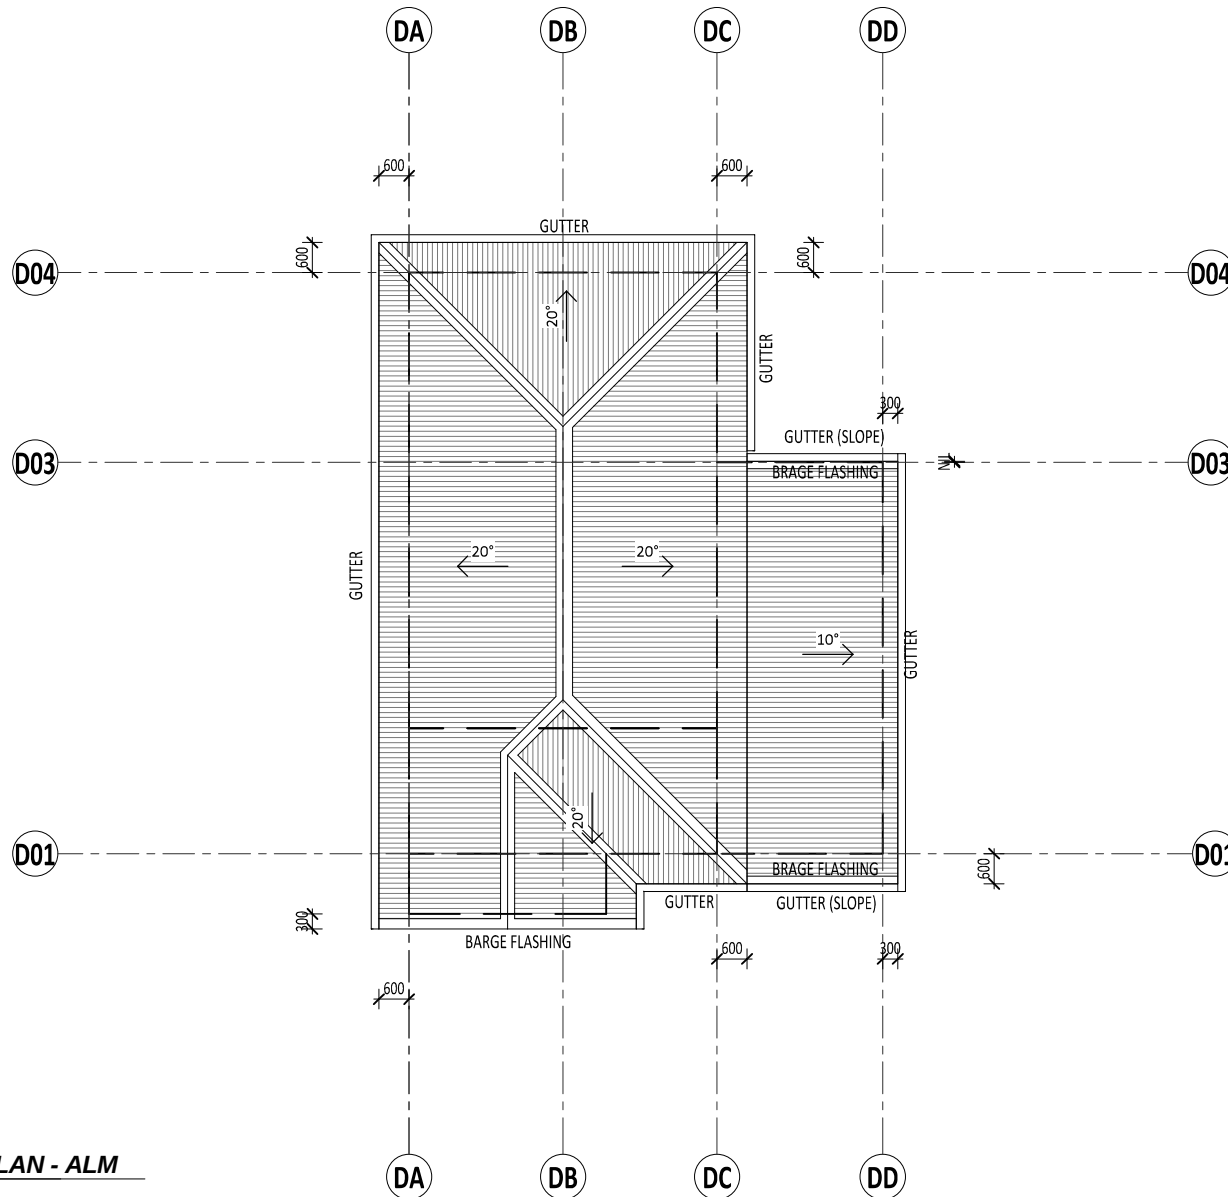

1 ROOF PLAN - ALM
AA04.01/ 1 : 100




dbARCH
planning
architecture
interior design
project management
1-3 Clacherty Street | PO Box 191
Stratford QLD 4870 Australia
+61 7 4058 0290 | www.dbarch.com.au

 

Drawing Status
PRELIMINARY ISSUE

Scale
0m 1m 2m 3m 4m 5m
SCALE 1:100

Revision Schedule	
P4 PRELIMINARY ISSUE	08.11.17
P3 PRELIMINARY ISSUE	06.07.17
P2 PRELIMINARY ISSUE	21.06.17
P1 PRELIMINARY ISSUE	20.06.17
Rev Description	Date

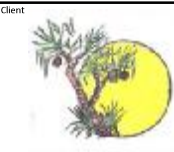


Project Manager /
Structural Engineer:
LANDSCAPE & DESIGN
LANDSCAPE ARCHITECTS

Drawn
Author
Date
08.11.17
Verification
Checker
Partner
Designer

Site information:

Project Description VARIOUS HOUSING	
Drawing Title ROOF PLAN - ALM STREET	Scale 1 : 100 @ A3
Master Site Number 17HAI01	Drawing Number AD02.02
	Revision P 4


NOTE: This drawing is copyright and the property of dbARCH and must not be used without written authorisation. **DO NOT SCALE THIS DRAWING.** All dimensions are to be verified onsite and any discrepancies reported before commencement of any work or shop drawings.

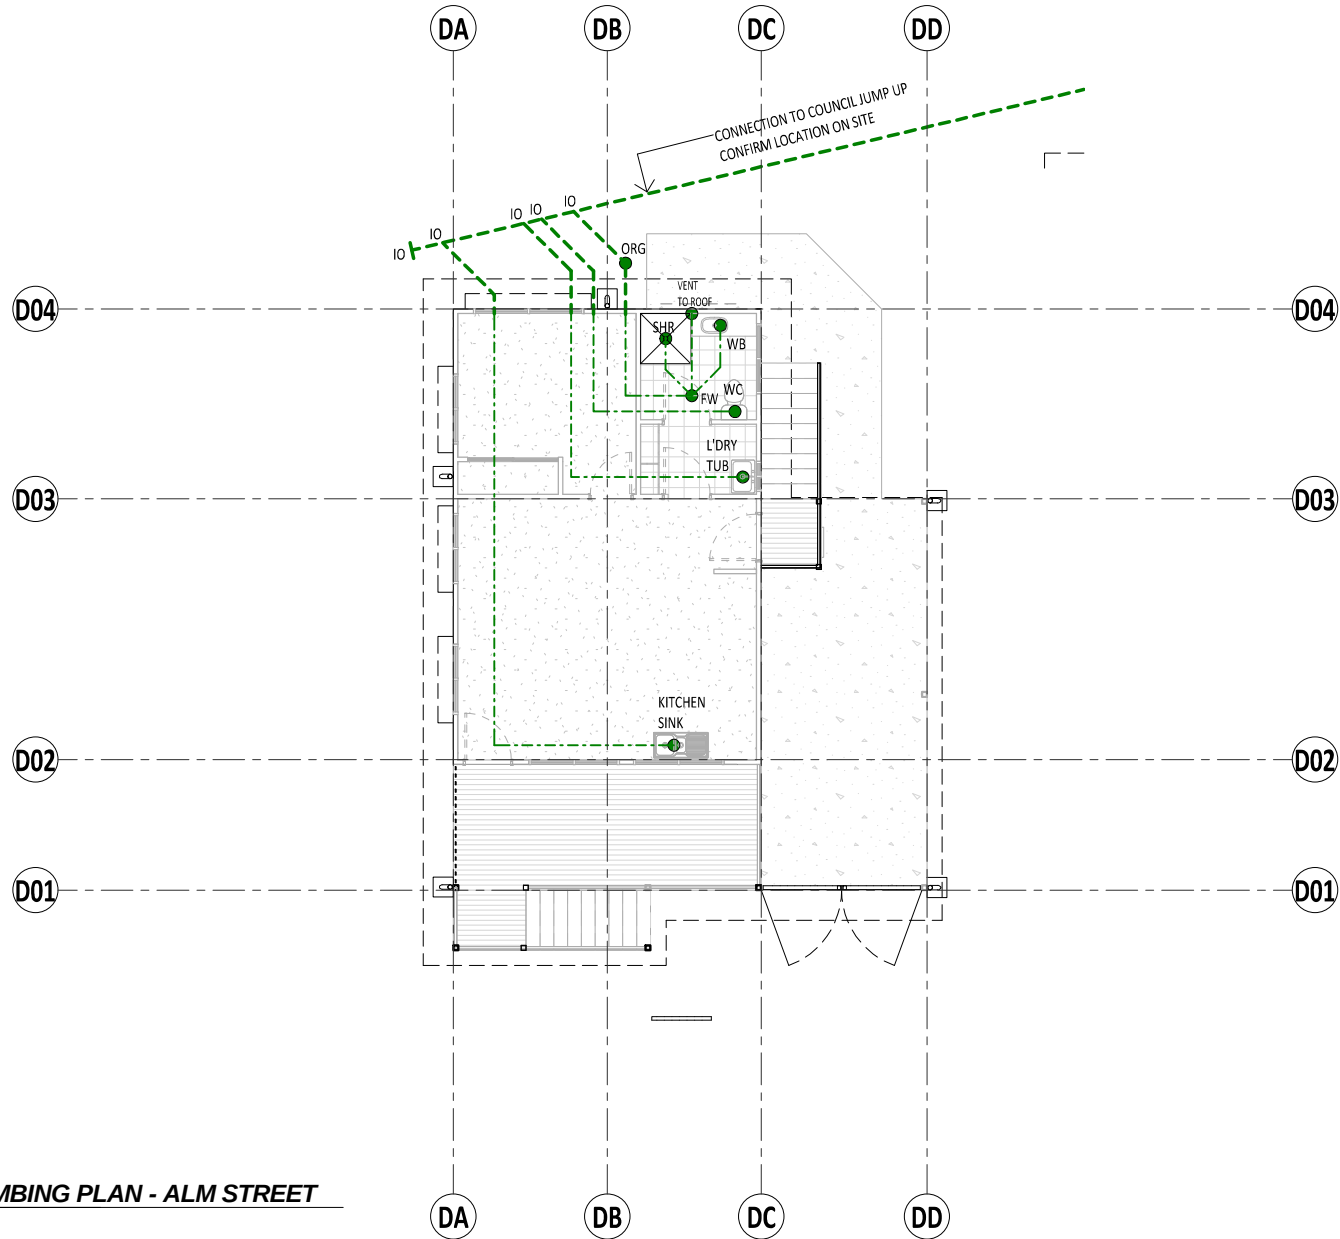

1 PLUMBING PLAN - ALM STREET
AA04.01 1 : 100




dbARCH
planning
architecture
interior design
project management
1-3 Clacherty Street | PO Box 191
Stratford QLD 4870 Australia
+61 7 4058 0290 | www.dbarch.com.au

 

Drawing Status
PRELIMINARY ISSUE
Scale
0m 0m 0m 0m 0m 0m
SCALE 1:0

Revision Schedule
P 1 PRELIMINARY ISSUE 08.11.17
Rev Description Date

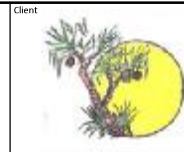


Project Manager /
Structural Engineer:
LANDSCAPE & DESIGN
LANDSCAPE ARCHITECTS

Drawn
Author
Date
08.11.17
Verification
Checker
Partner
Designer

Site information:

Project Description
VARIOUS HOUSING
Drawing Title
PLUMBING PLAN - ALM STREET Scale
1 : 100 @ A3
Master Site Number Drawing Number Revision
17HAI01 AD03.01 P 1

NOTE: This drawing is copyright and the property of dbARCH and must not be used without written authorisation. **DO NOT SCALE THIS DRAWING.** All dimensions are to be verified onsite and any discrepancies reported before commencement of any work or shop drawings.

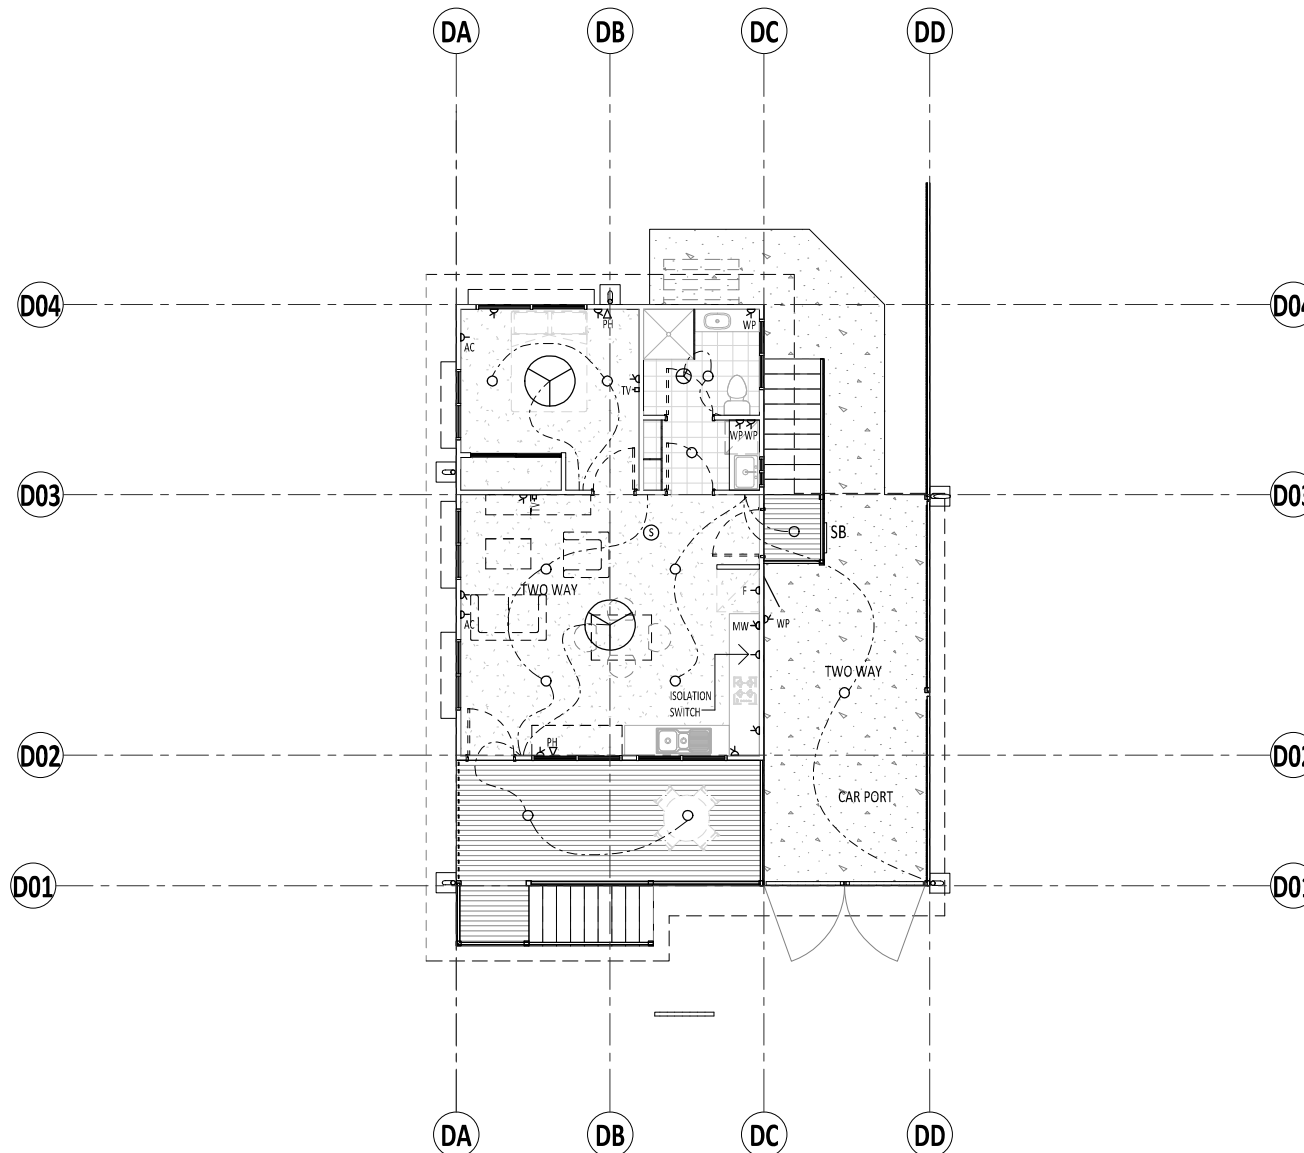


LEGEND:

	FLURO LIGHT
	SWITCHBOARD
	FAN
	EXHAUST FAN
	SMOKE ALARM
	OYSTER LIGHT
	GPO
	TV AERIAL SOCKET
	PHONE SOCKET


1 ELECTRICAL PLAN - ALM
AA04.01 1 : 100

	dbARCH planning architecture interior design project management 1-3 Clacherty Street PO Box 191 Stratford QLD 4870 Australia +61 7 4058 0290 www.dbarch.com.au		Drawing Status PRELIMINARY ISSUE Scale 0m 1m 2m 3m 4m 5m  SCALE 1:100	Revision Schedule <table><tr><td>P 4 PRELIMINARY ISSUE</td><td>08.11.17</td></tr><tr><td>P 3 PRELIMINARY ISSUE</td><td>06.07.17</td></tr><tr><td>P 2 PRELIMINARY ISSUE</td><td>21.06.17</td></tr><tr><td>P 1 PRELIMINARY ISSUE</td><td>20.06.17</td></tr></table> Rev Description Date	P 4 PRELIMINARY ISSUE	08.11.17	P 3 PRELIMINARY ISSUE	06.07.17	P 2 PRELIMINARY ISSUE	21.06.17	P 1 PRELIMINARY ISSUE	20.06.17		Project Manager / Structural Engineer: 	Drawn Author Date 08.11.17 Verification Checker Partner Designer	Site information:	Project Description VARIOUS HOUSING Drawing Title ELECTRICAL PLAN - ALM STREET Master Site Number 17HAI01 Drawing Number AD03.02	Scale As indicated @ A3 Revision P 4
	P 4 PRELIMINARY ISSUE				08.11.17													
	P 3 PRELIMINARY ISSUE				06.07.17													
	P 2 PRELIMINARY ISSUE				21.06.17													
P 1 PRELIMINARY ISSUE	20.06.17																	


NOTE: This drawing is copyright and the property of dbARCH and must not be used without written authorisation. **DO NOT SCALE THIS DRAWING.** All dimensions are to be verified onsite and any discrepancies reported before commencement of any work or shop drawings.

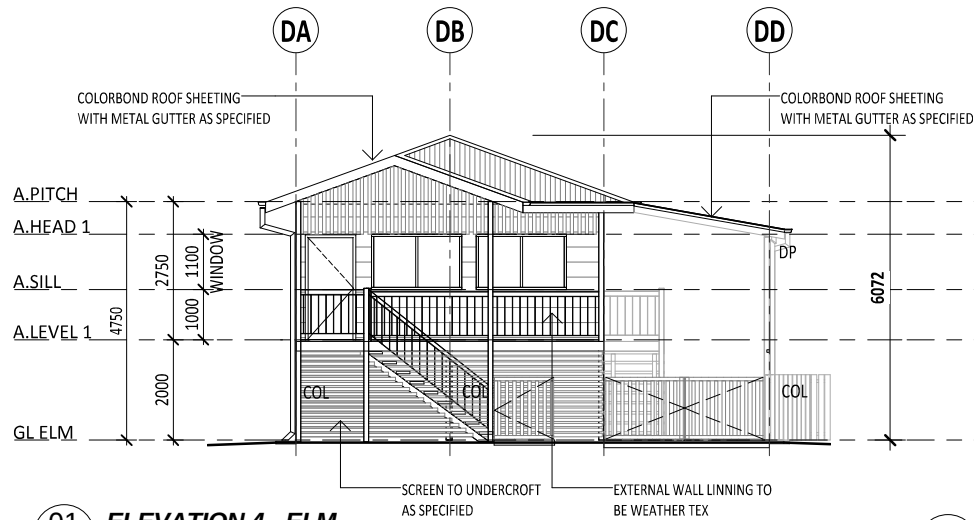


01 ELEVATION 4 - ELM
AD02.01 1 : 100

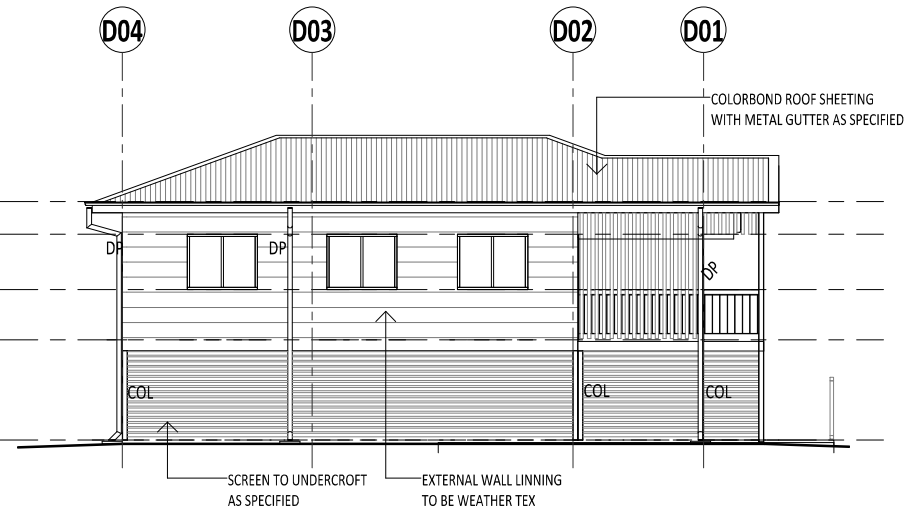

02 ELEVATION 1 - ELM
AD02.01 1 : 100

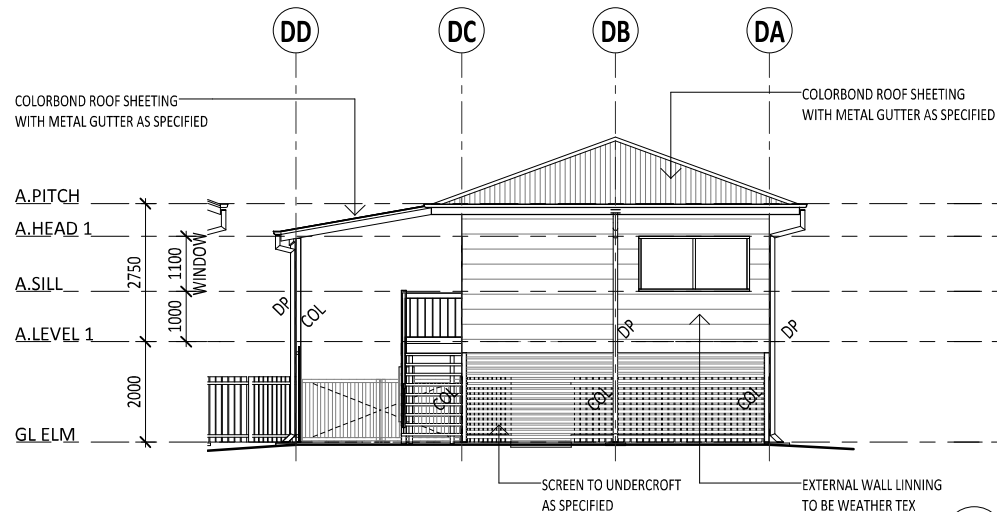

03 ELEVATION 2 - ELM
AD02.01 1 : 100

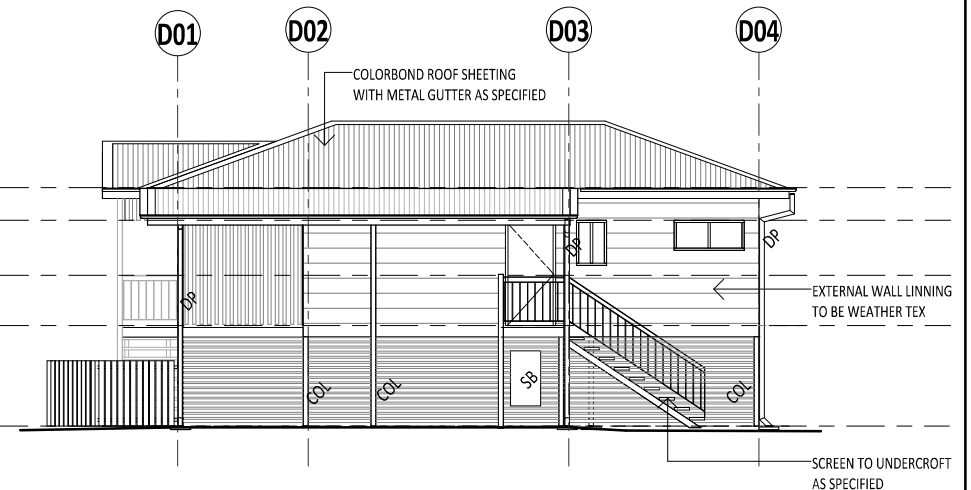

04 ELEVATION 3 - ELM
AD02.01 1 : 100



dbARCH
planning
architecture
interior design
project management
1-3 Clacherty Street | PO Box 191
Stratford QLD 4870 Australia
+61 7 4058 0290 | www.dbarch.com.au

North

Drawing Status

PRELIMINARY ISSUE

Scale

0m 1m 2m 3m 4m 5m

SCALE 1:100

Revision Schedule

P4 PRELIMINARY ISSUE	08.11.17
P3 PRELIMINARY ISSUE	06.07.17
P2 PRELIMINARY ISSUE	21.06.17
P1 PRELIMINARY ISSUE	20.06.17
Rev Description	Date

Client



Project Manager /
Structural Engineer:

LANDSCAPE & DESIGN
LANDSCAPE ARCHITECTS

LANDSCAPE ARCHITECTS

LANDSCAPE ARCHITECTS

LANDSCAPE ARCHITECTS

Drawn
Author

Date
08.11.17

Verification
Checker

Partner
Designer

Site information:

Project Description
VARIOUS HOUSING

Drawing Title
ELEVATION SHEET - ALM STREET


Master Site Number
17HA101

Drawing Number
AD04.01

Scale
1 : 100 @
A3
Revision
P 4

NOTE: This drawing is copyright and the property of dbARCH and must not be used without written authorisation. **DO NOT SCALE THIS DRAWING.** All dimensions are to be verified onsite and any discrepancies reported before commencement of any work or shop drawings.

**STEP WET AREA JOISTS TO ACHIEVE
NIL STEP INTO ROOMS AND ALLOW
FOR WATERPROOFING**

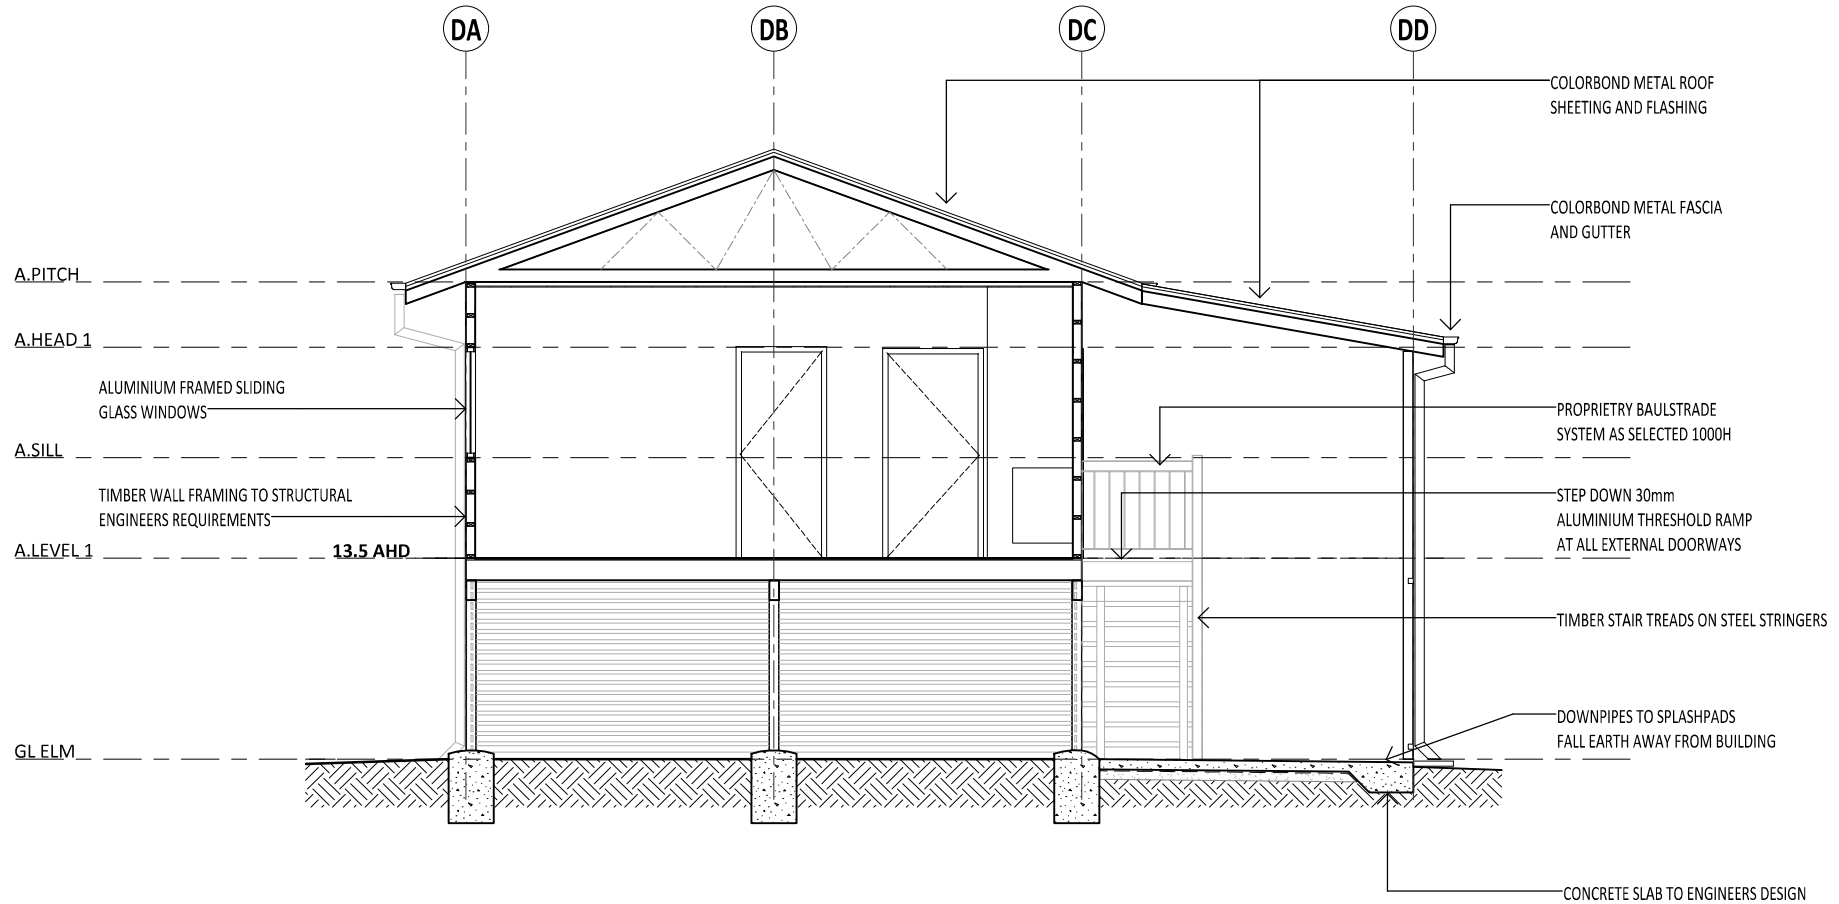

1

Section 1

1 : 50



dbARCH
planning
architecture
interior design
project management
1-3 Clacherty Street | PO Box 191
Stratford QLD 4870 Australia
+61 7 4058 0290 | www.dbarch.com.au

North

Drawing Status

PRELIMINARY ISSUE

Scale

0m 0m 0m 0m 0m 0m
SCALE 1:0

Revision Schedule

P 1 PRELIMINARY ISSUE
Rev Description

08.11.17
Date

Client



Project Manager /
Structural Engineer:

LANDSCAPE & DESIGN
INTERIOR - EXTERIOR - ROOFS

Drawn

Author

Date

08.11.17

Verification

Checker

Partner

Designer

Site information:

Project Description

VARIOUS HOUSING

Drawing Title
SECTION SHEET - ALM STREET

Scale
1 : 50 @ A3

Master Site Number

17HAI01

Drawing Number

AD04.02

Revision

P 1

NOTE: This drawing is copyright and the property of dbARCH and must not be used without written authorisation. **DO NOT SCALE THIS DRAWING.** All dimensions are to be verified onsite and any discrepancies reported before commencement of any work or shop drawings.