
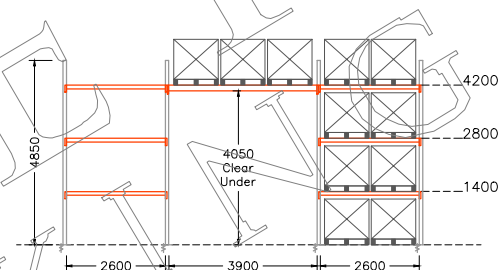
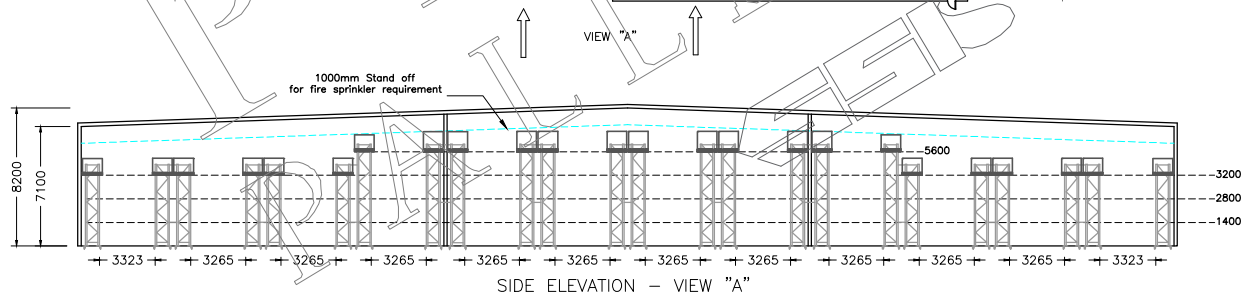


1


2

3


4

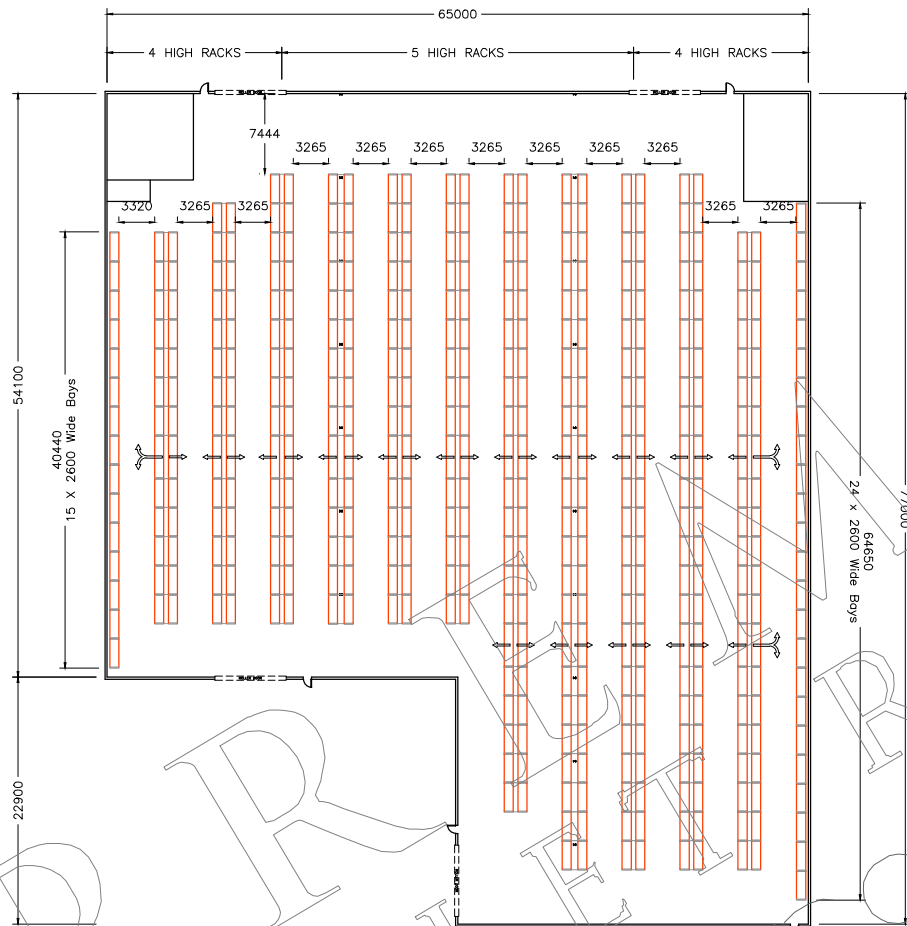

TYPICAL FRONT ELEVATION  
4 HIGH RACKS

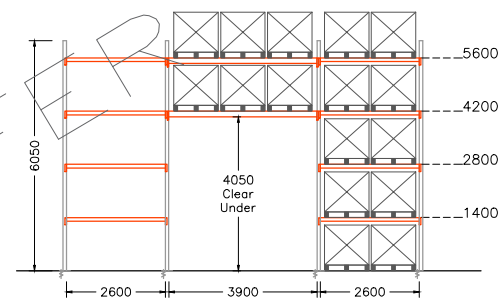


TYPICAL FRONT ELEVATION  
5 HIGH RACKS

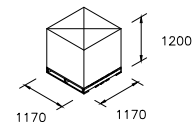

TYPICAL PALLET

AUSTRALIAN STANDARD PALLET  
(1200H x 1170W x 1170D)  
Weight: 1000kg UDL  
Total Pallet Positions: Whse.D2 3,769

 SIDE ELEVATION - VIEW "A"



DRAWING FOR QUOTATION ONLY

FINAL LAYOUT SUBJECT TO FULL SITE SURVEY

DRAWING APPROVAL:

APPROVAL BY (PRINT NAME & SIGNATURE):

POSITION: \_\_\_\_\_ DATE: \_\_\_\_\_

COMMENT: \_\_\_\_\_

THE PROPOSED LAYOUT IS CONCEPTUAL ONLY. IT IS THE CLIENT RESPONSIBILITY TO ENSURE ALL STATUTORY & BUILDING CODE REQUIREMENTS ARE MET. THE PROPOSED LAYOUT HAS BEEN PROVIDED AS A GUIDE FOR THE CLIENT PLANNING PURPOSES. IT IS ASSUMED THE EXISTING SURFACE ONTO WHICH THE INSTALLATION IS TO BE BUILT IS CAPABLE OF SUPPORTING THE STRUCTURE INCLUDING ITS CONTENTS AND STRUCTURALLY ADEQUATE TO TAKE INDUCED LOADS AND FLOOR FIXING. WE RECOMMEND YOU OBTAIN INDEPENDENT VERIFICATION THAT THE EXISTING STRUCTURE IS CAPABLE OF SUSTAINING THE LOADS/FORCES.

Rev.	Description	By	Date	Chkd
REVE				
REVI				
REVC				
REVE				
REVA				
REVC				



**PREMIER  
PALLET RACKING**

PART OF THE AUTHORISED  
SSI SCHAEFER DISTRIBUTOR NETWORK.

ABN: 1300 724 584

SHED F  
SCHEMATIC PALLET RACKING FLOORPLAN

Drawing No.:  
Q200271

Rev No.:  
Sheet No.: 1

Size:  
A3

Drawn By: AW  
Checked:

Date: 25.04.2020  
Scale: NTS

1

2

3

4